
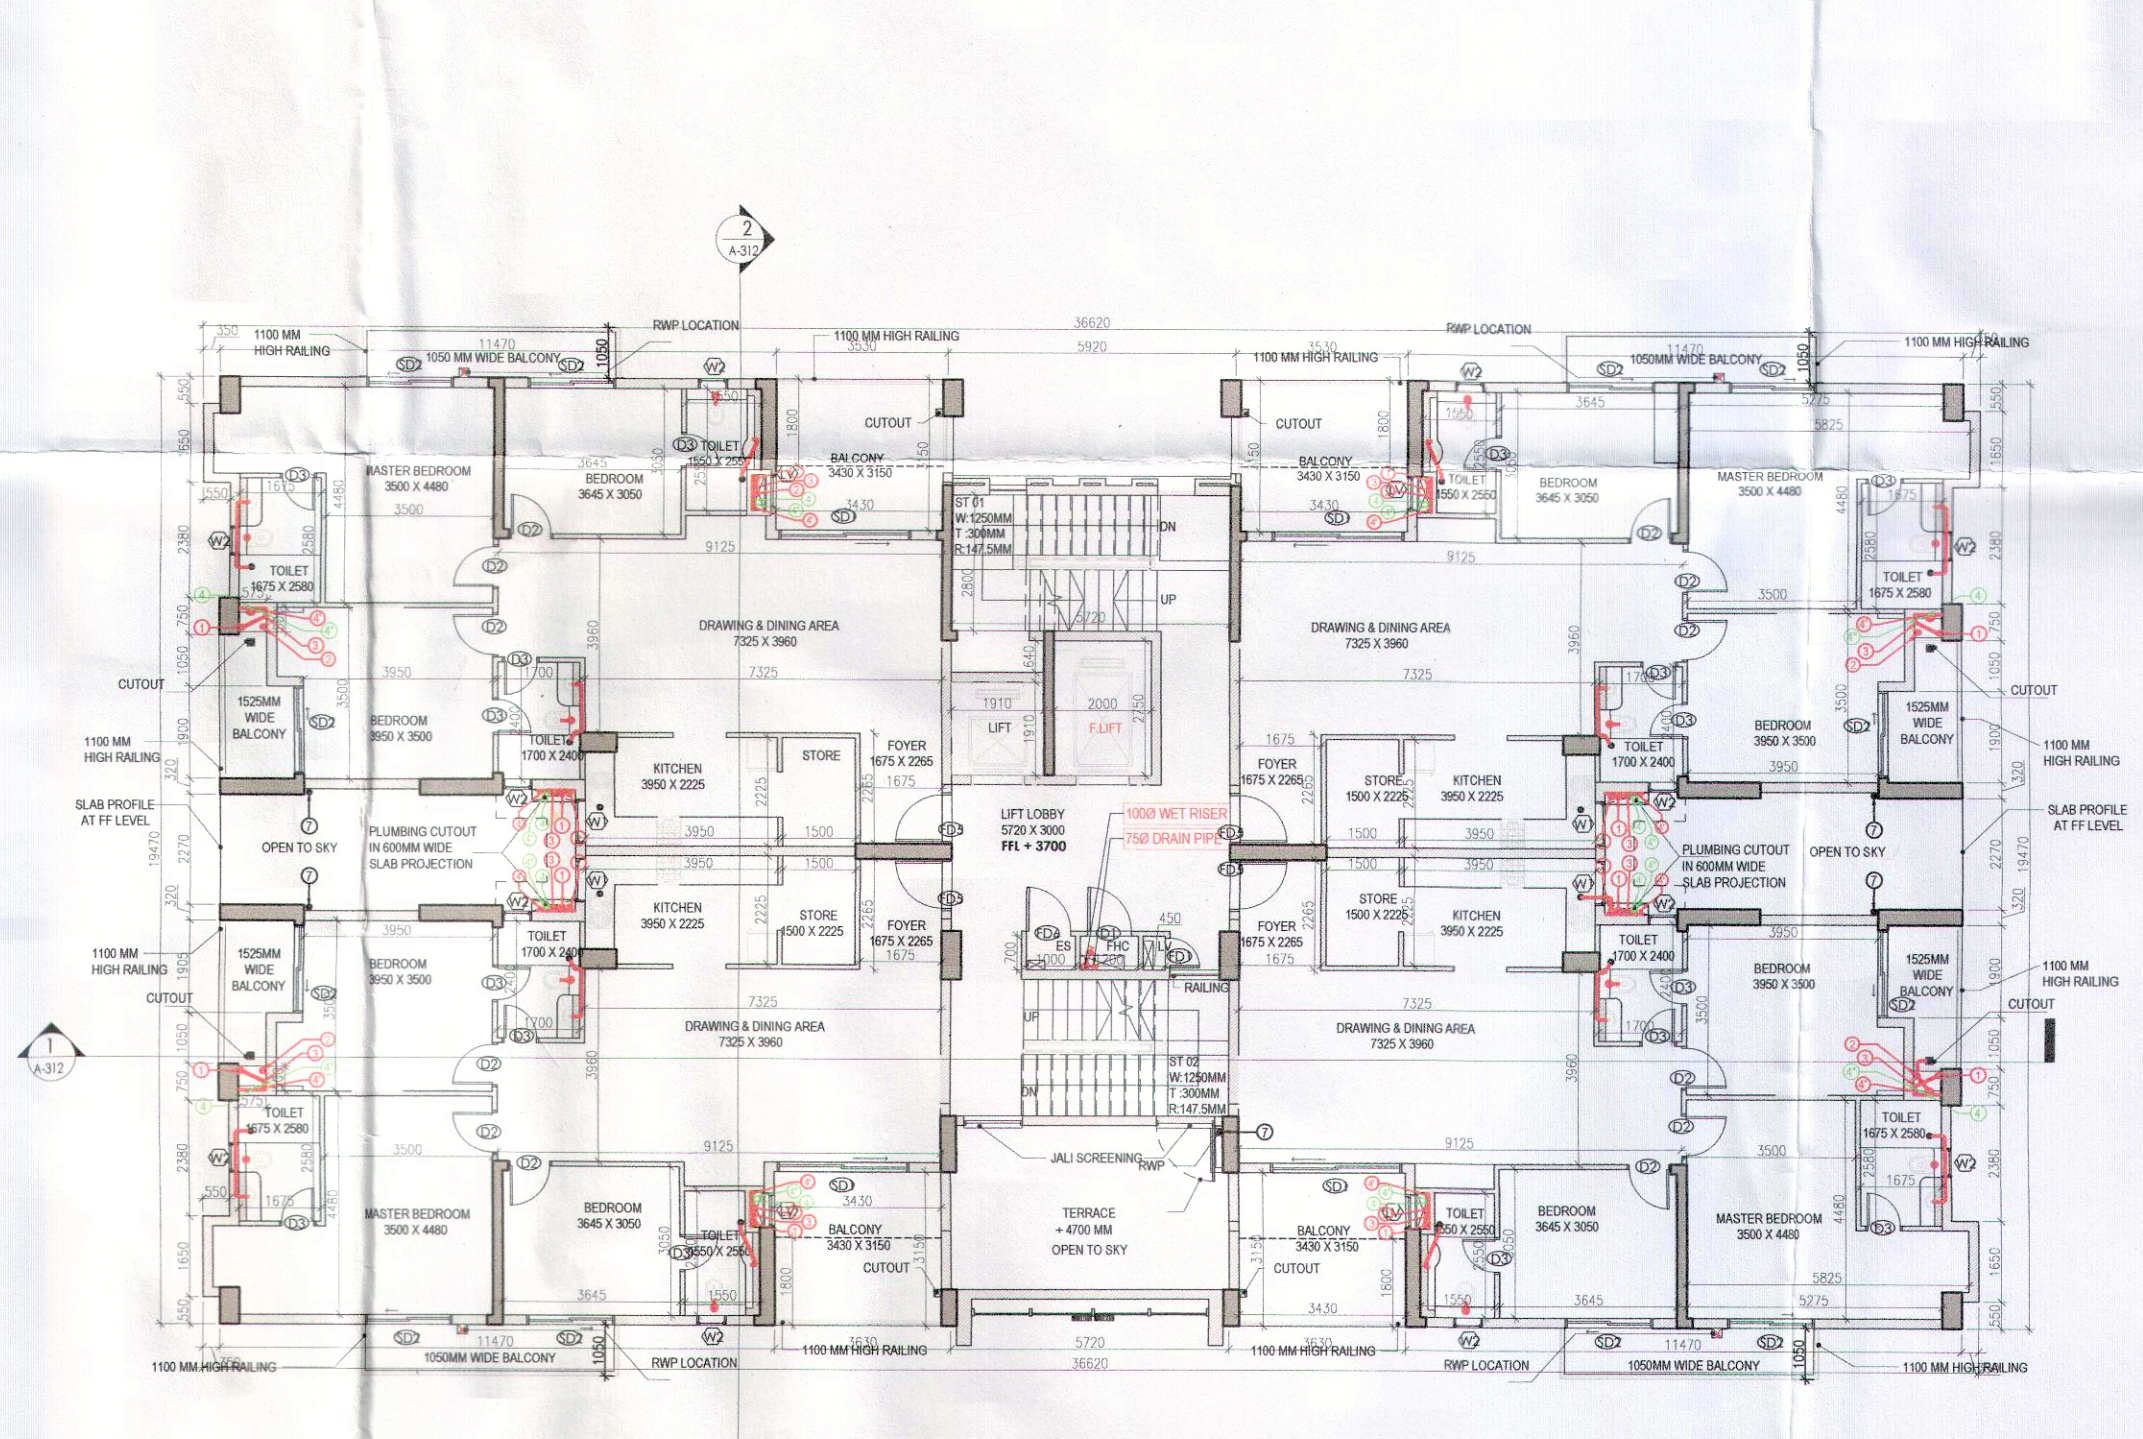
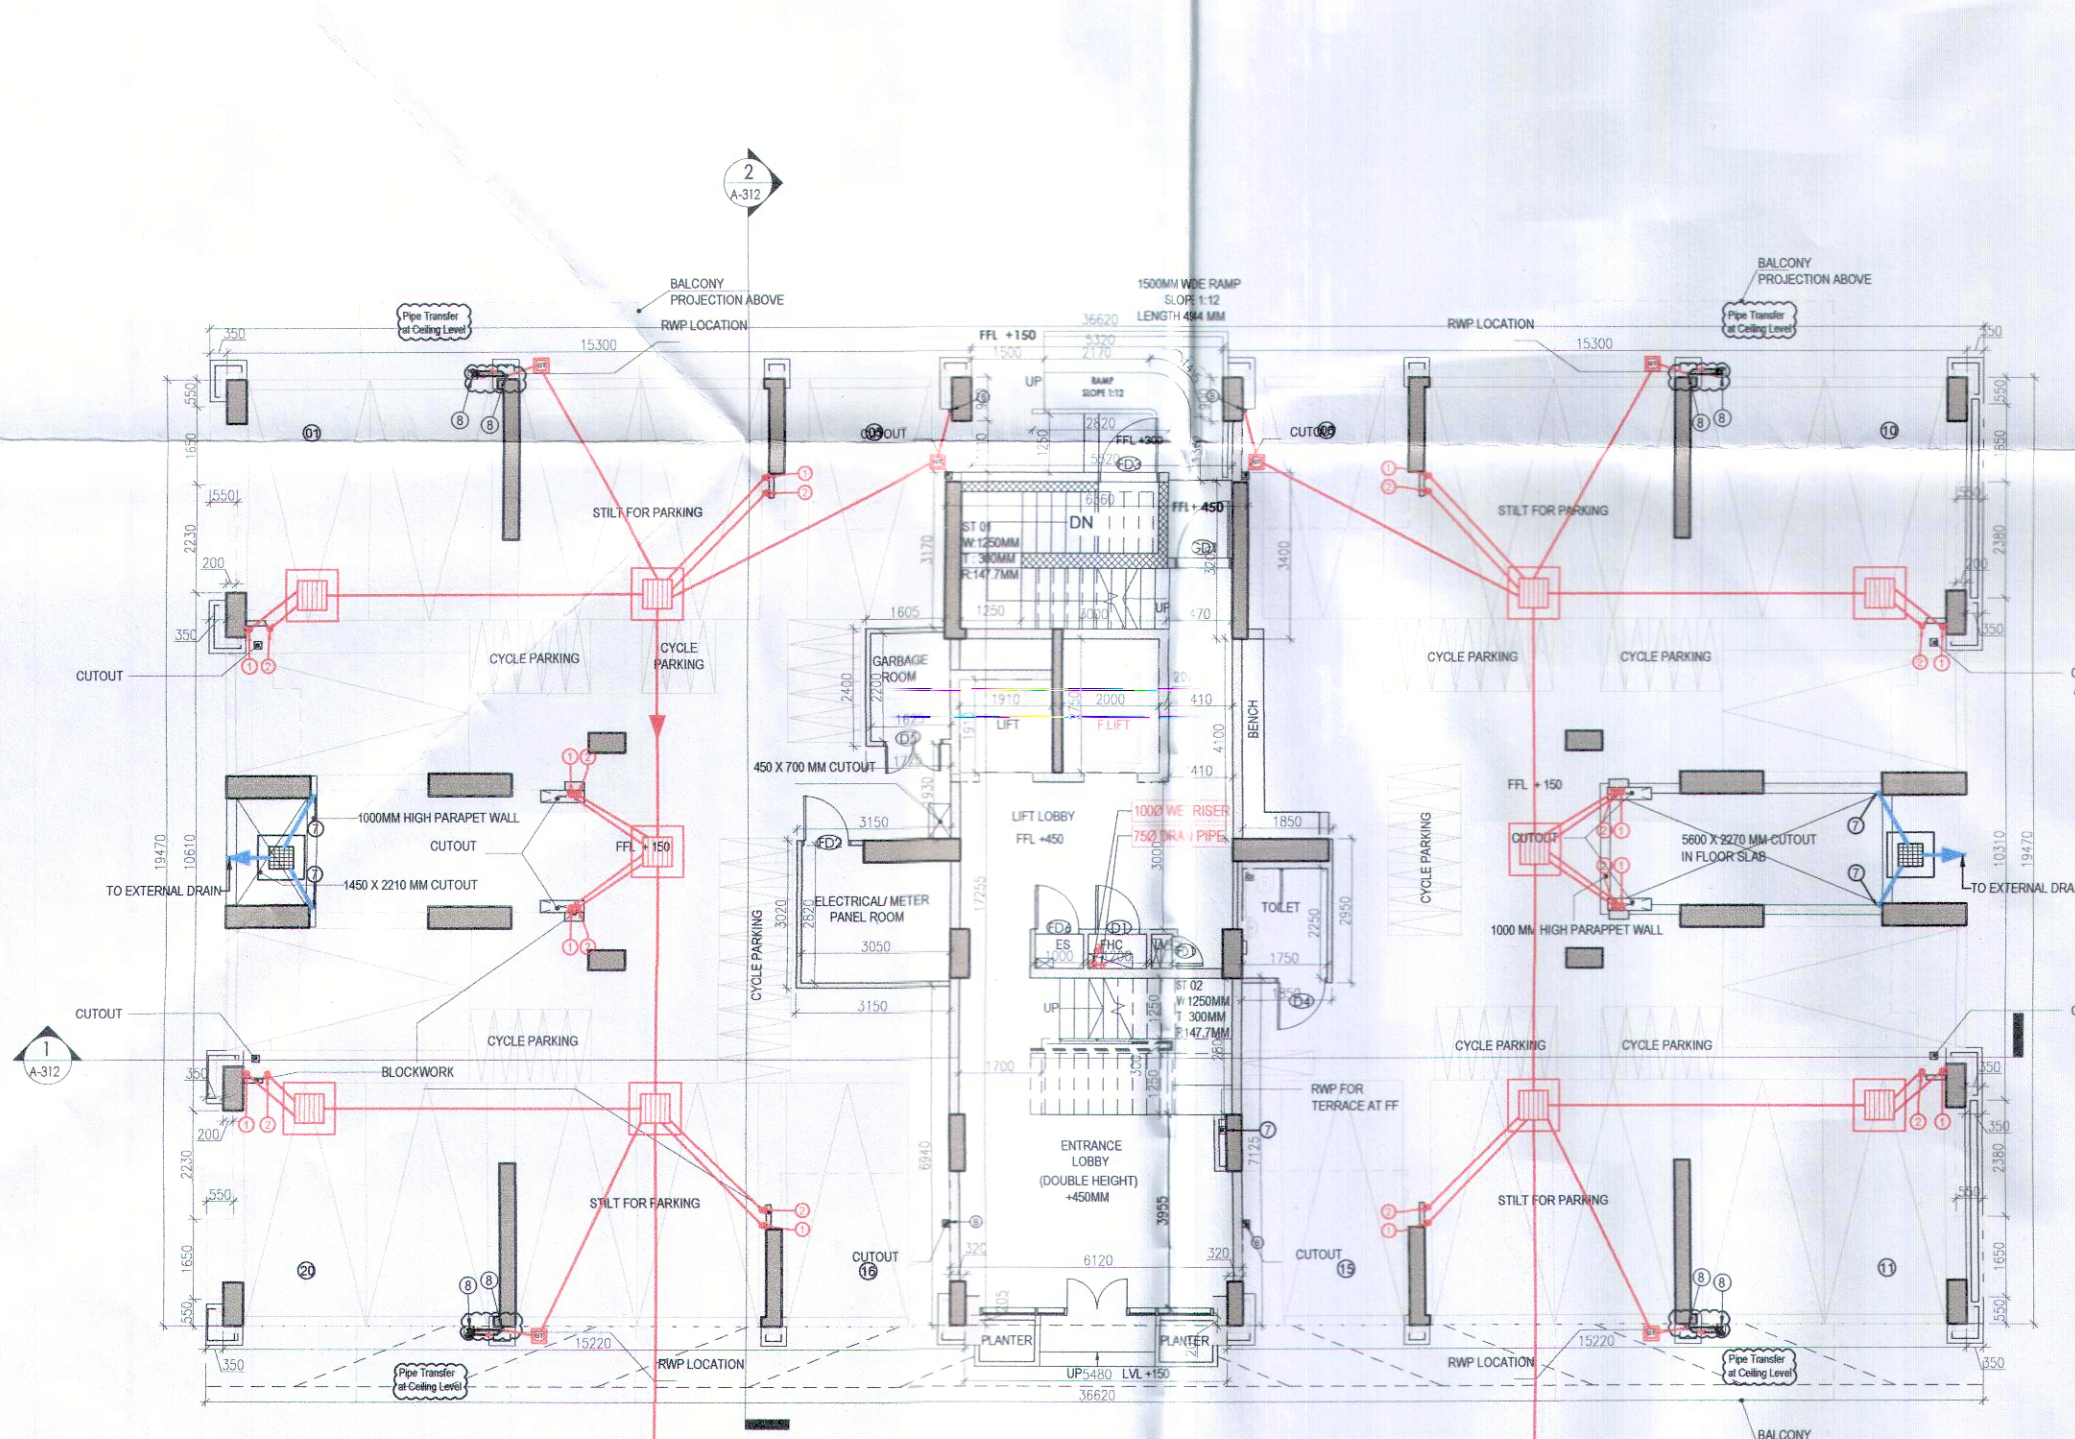
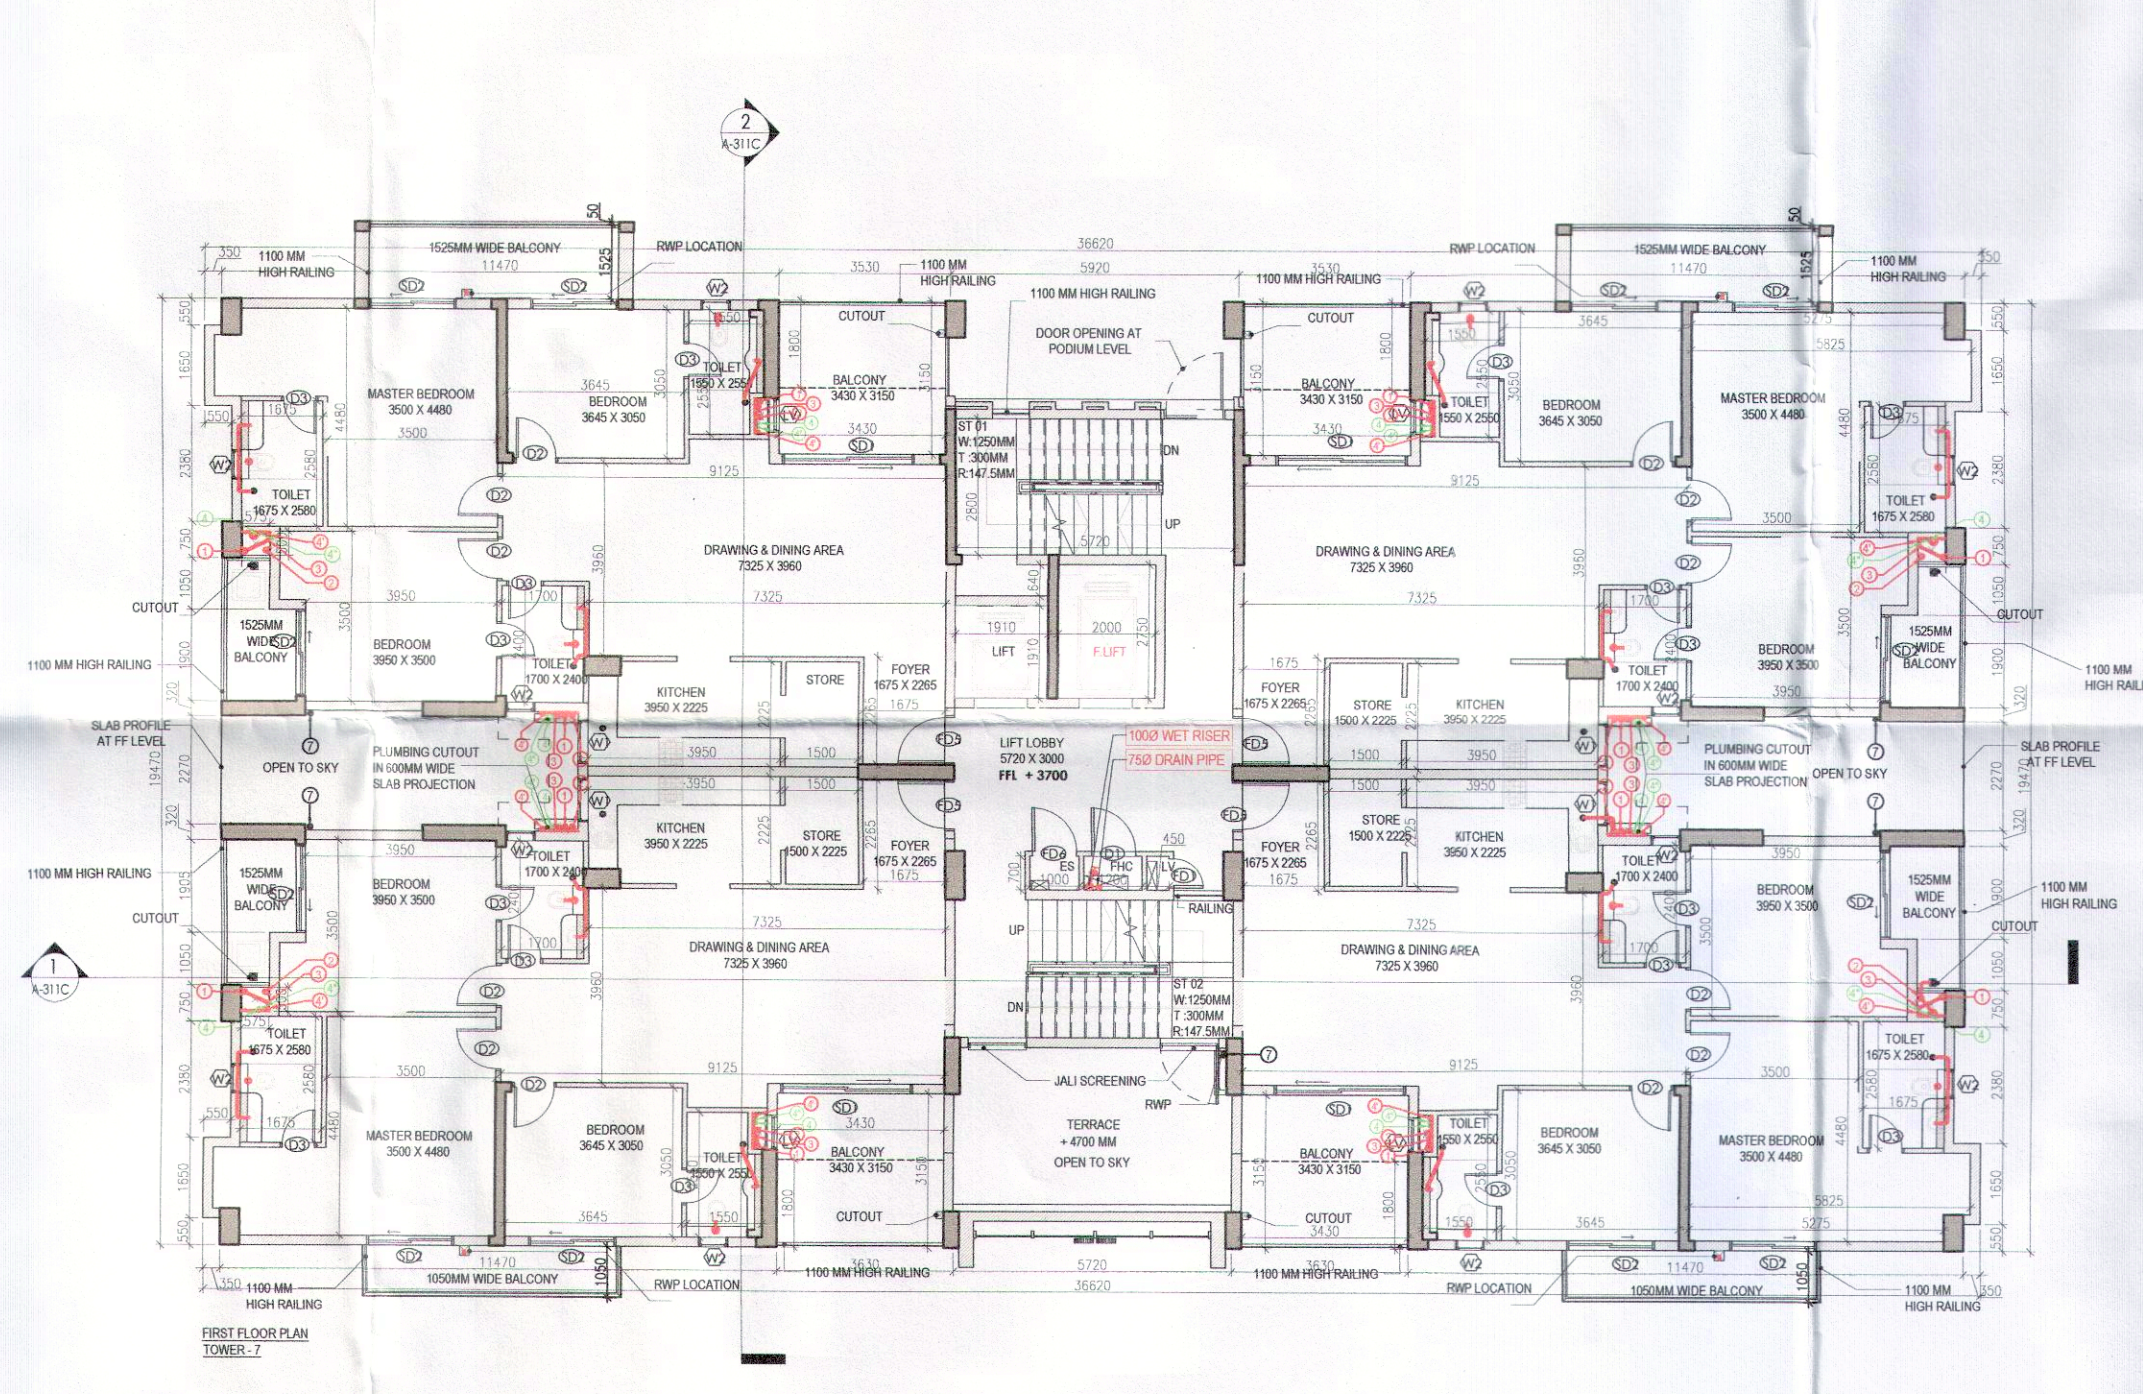
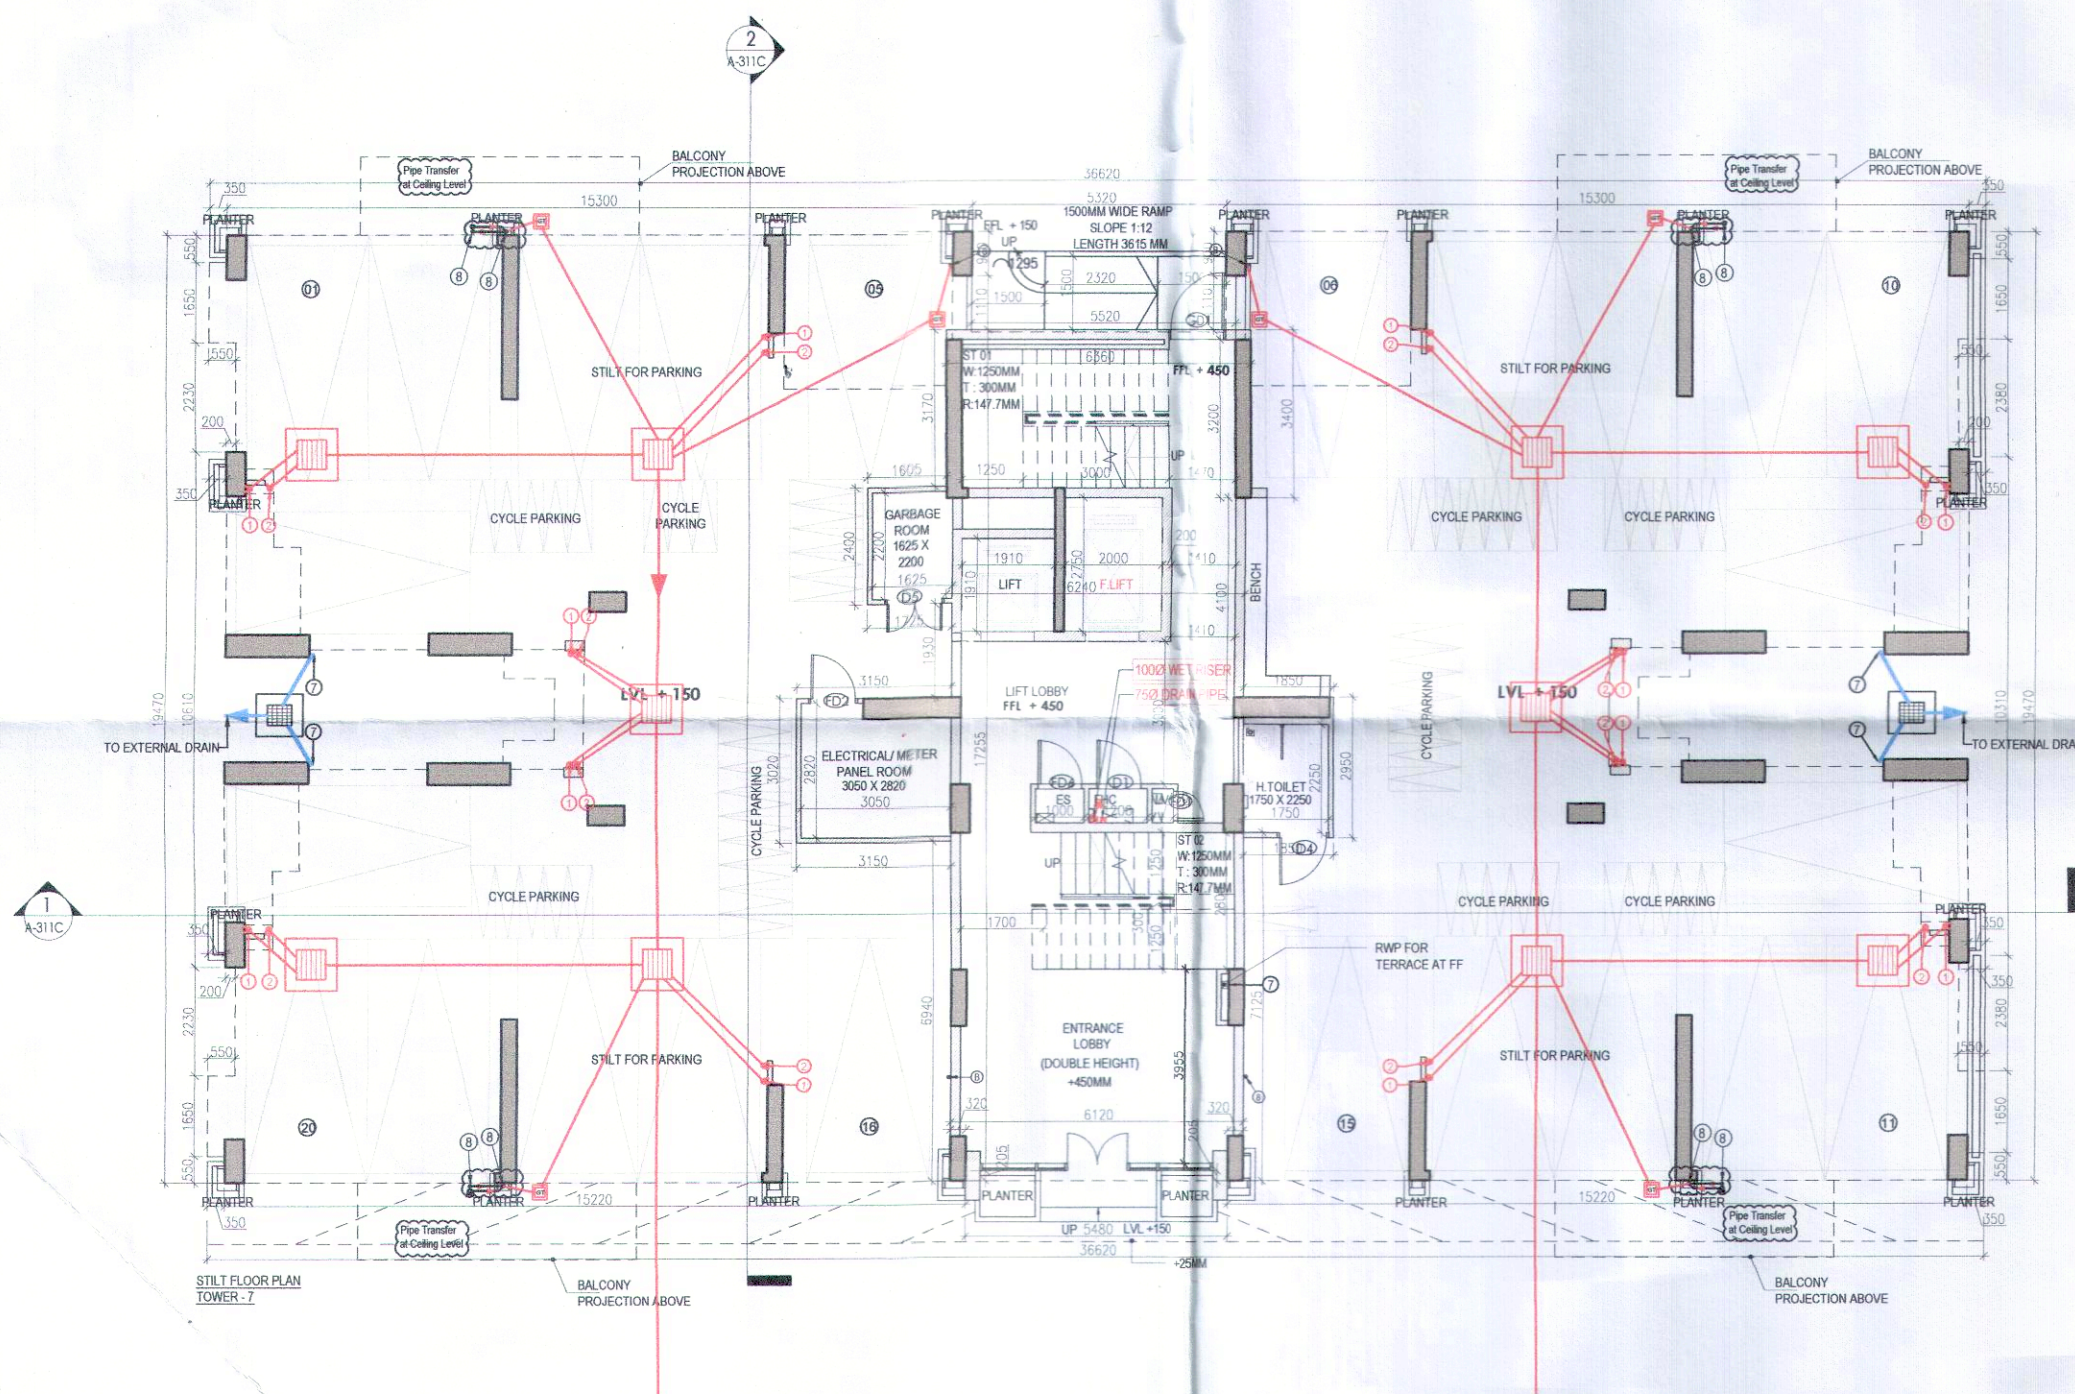
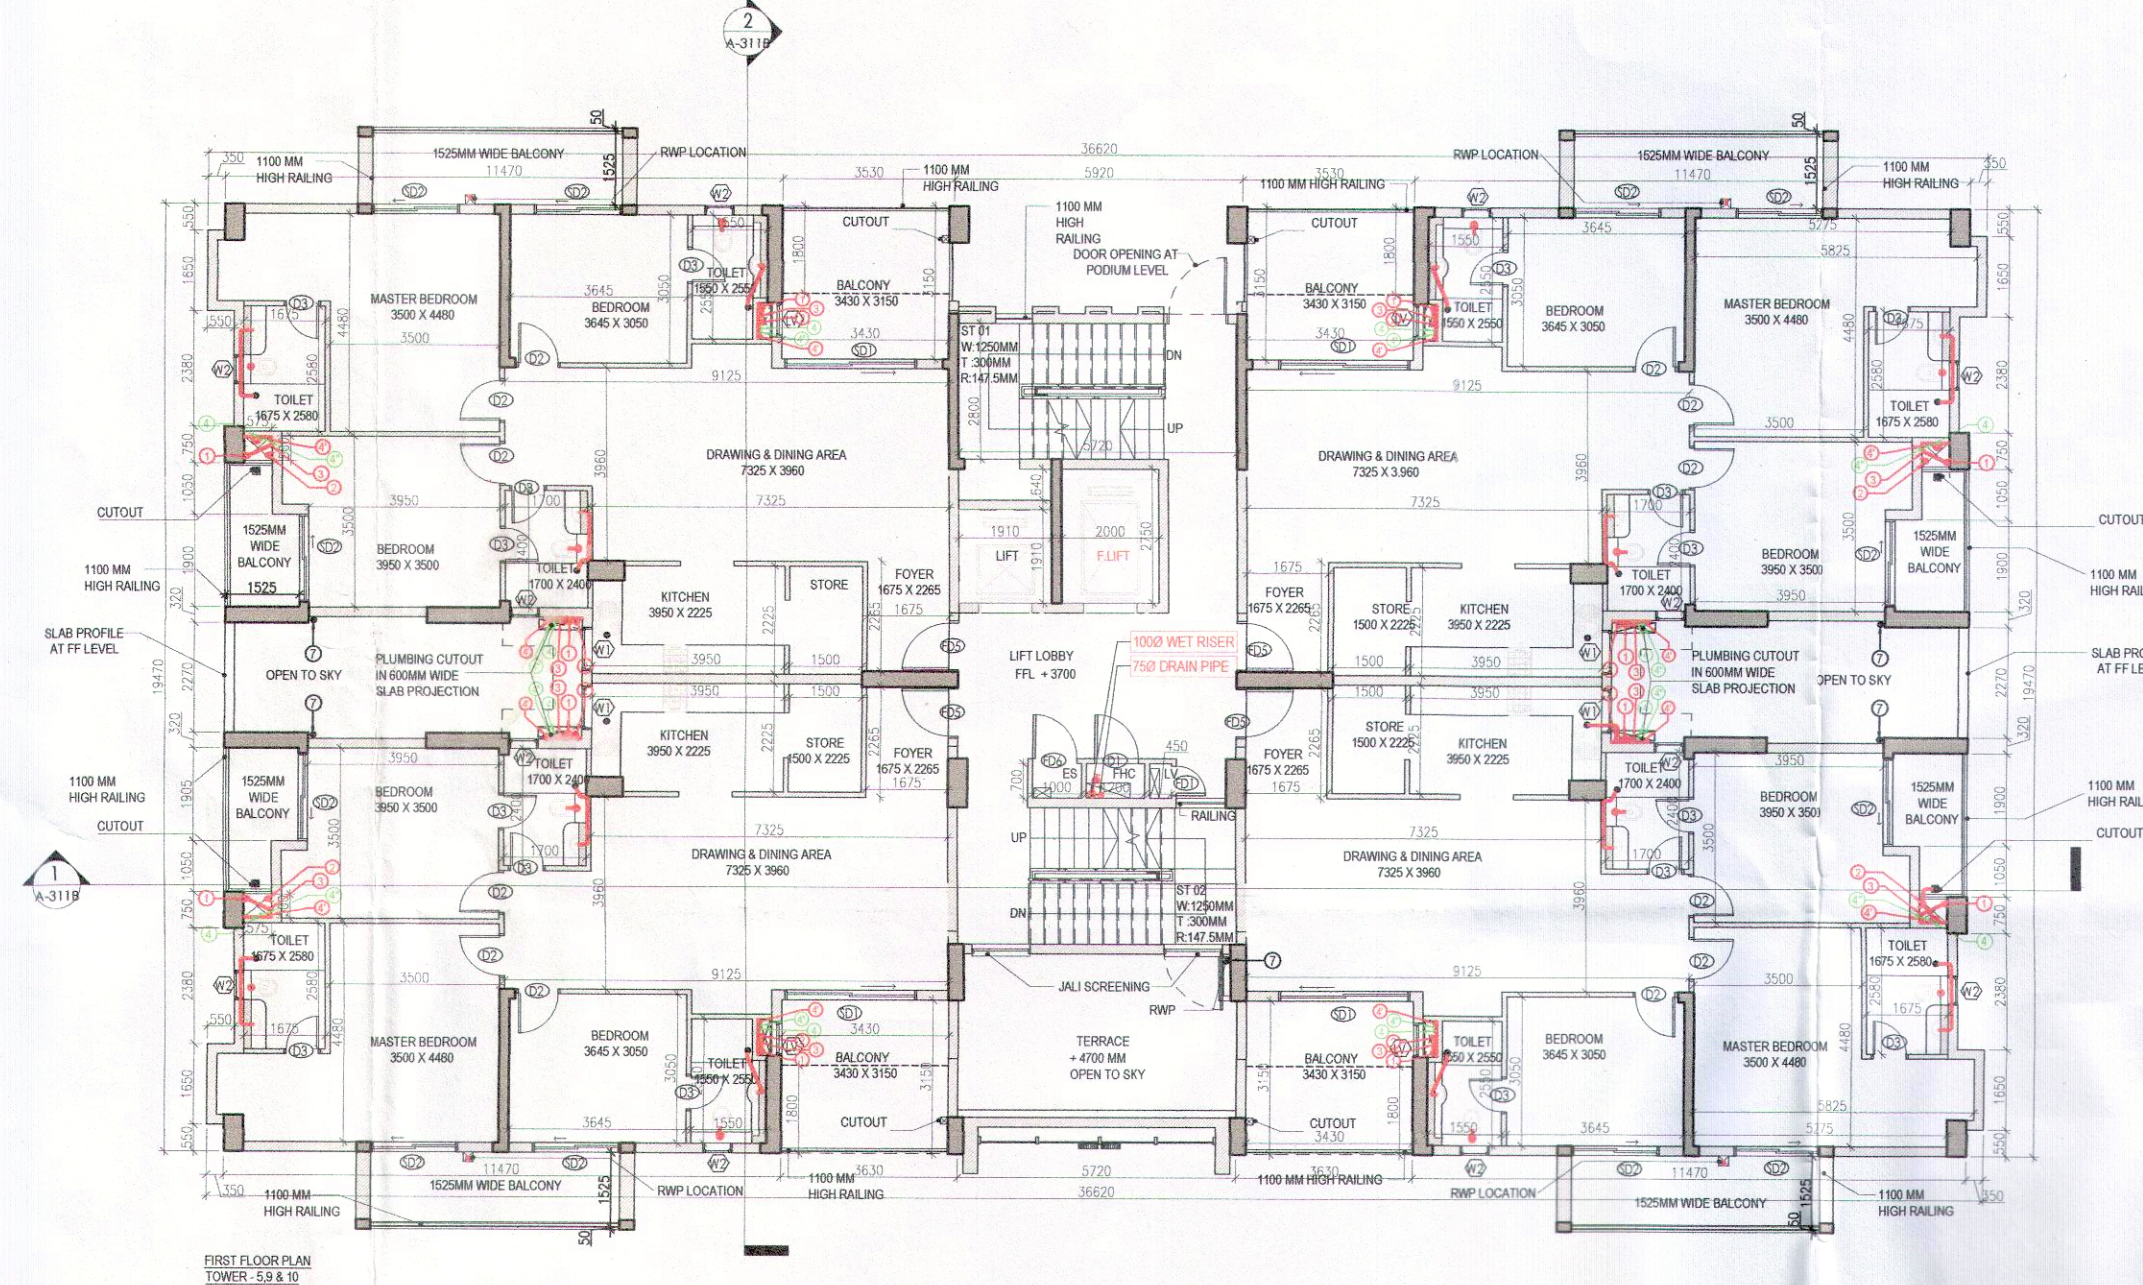


R.T.P. (H) Member B.P.A.C.
 S.T.P. (H) Member B.P.A.C.
 S.T.P. (G) Member B.P.A.C.
 S.T.P. (Hr) Chairman B.P.A.C.
 Consultant Architect
 (Dinesh Kumar) PAI(HQ)

TO BE READ WITH THIS OFFICE
 MEMO NO.:
 DATED:

Checked and found ok for Public Health (Internal) Service only subject to comments in in forwarding letter No.DV.....

Supervising Engineer (HQ)
 for Chief Engineering Officer
 H.S.V.P. P. S. Kulkarni
 I.D.E. S. V.

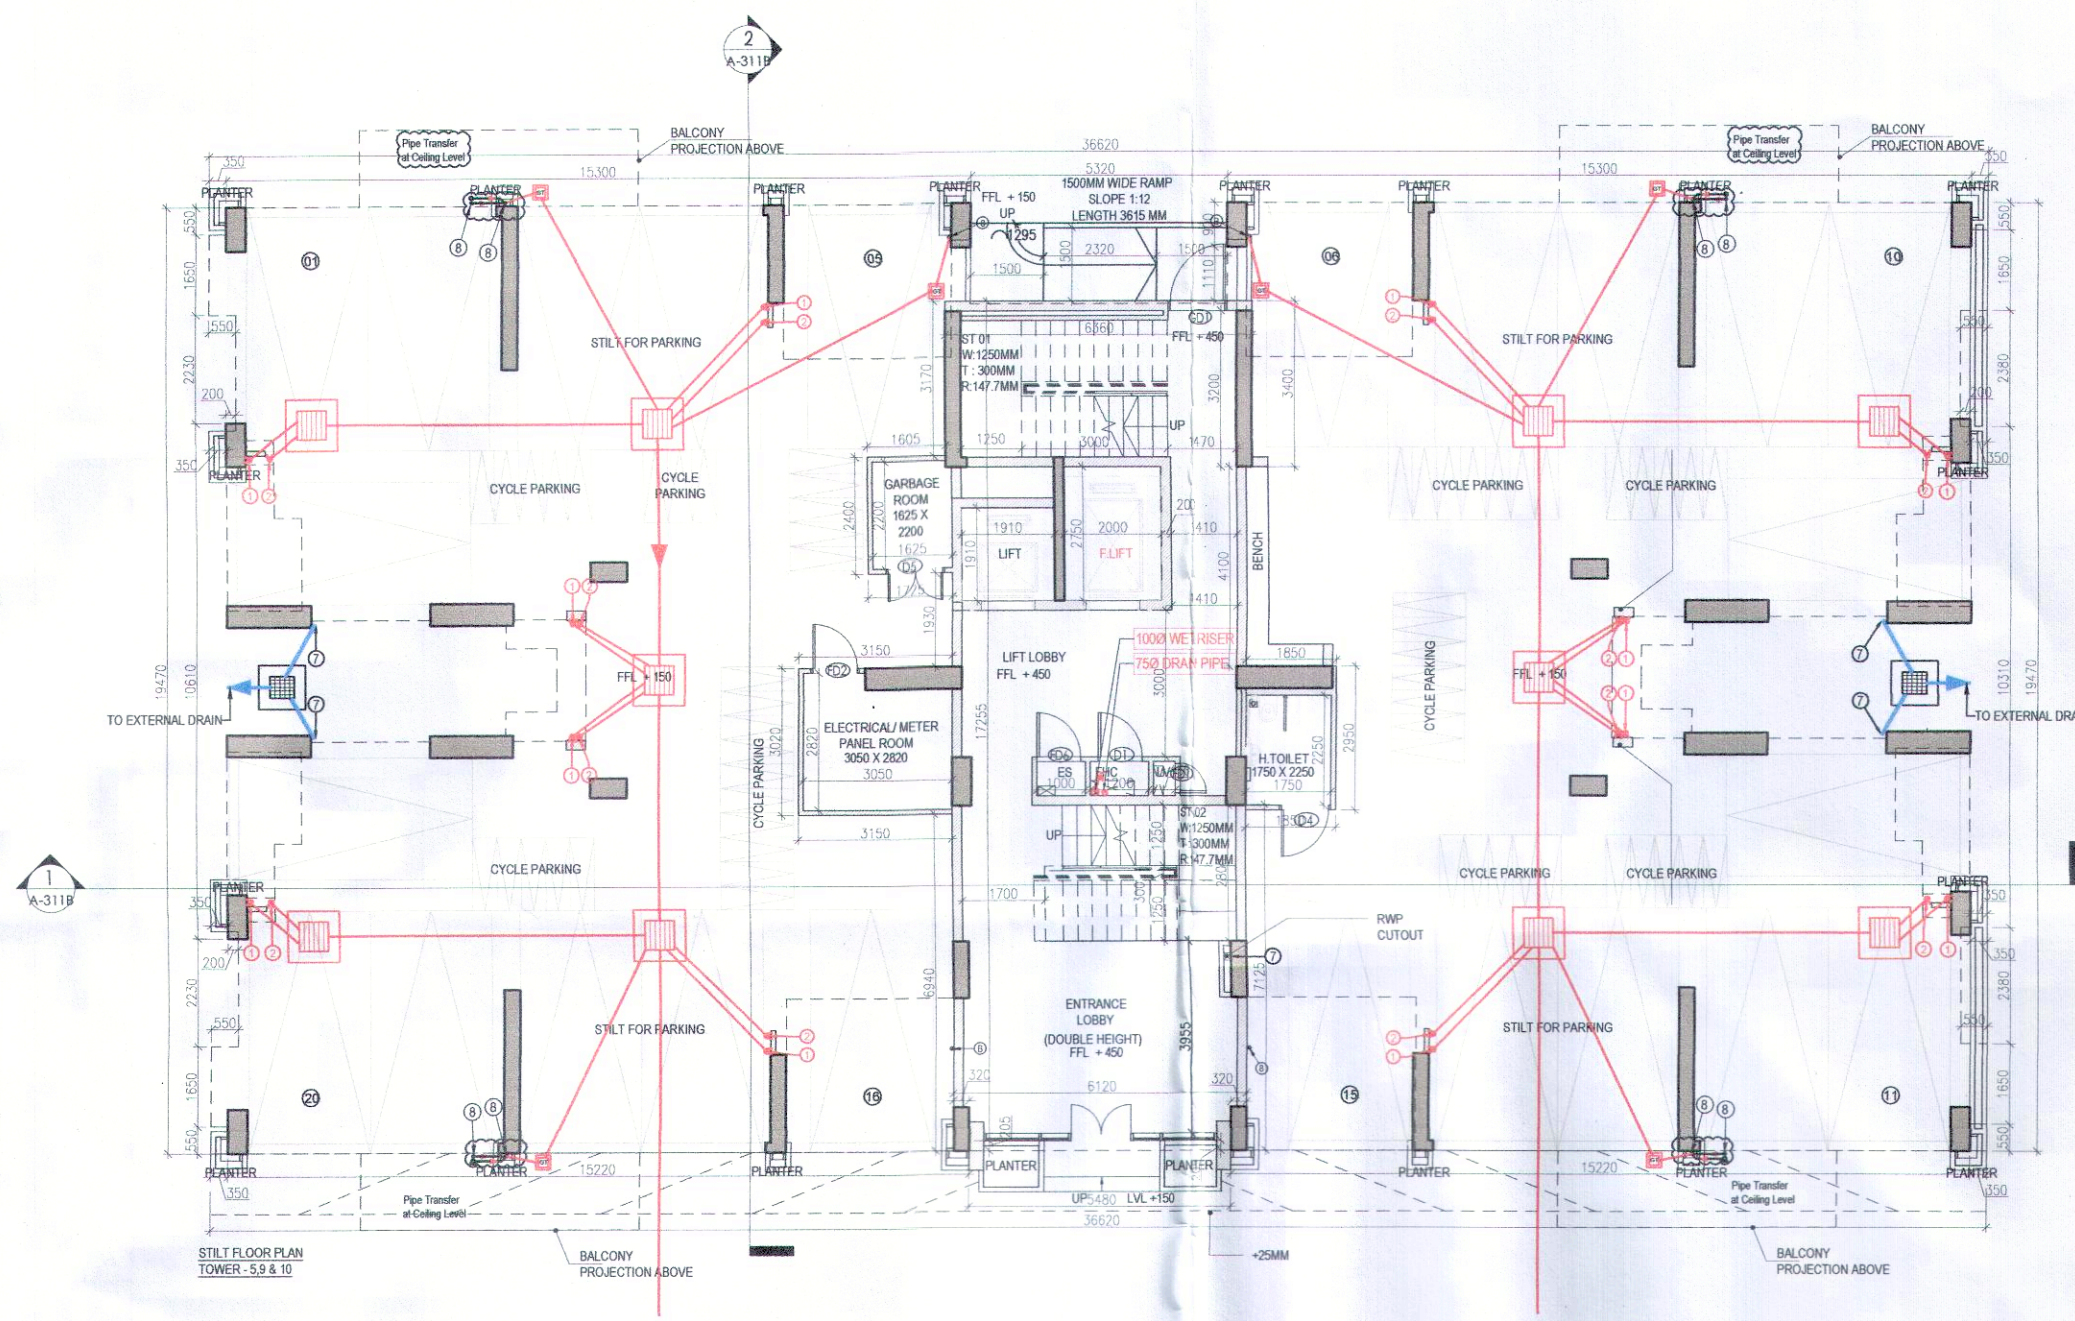

PLUMBING LEGEND	LEGEND
1. 110MM OD UPVC SP STACK	SYMBOL DESCRIPTION
2. 110MM OD UPVC WP STACK	SOIL PIPE
3. 75MM OD UPVC WP STACK	WASTE PIPE
4. DWS DITAKE	FT FLOOR TRAP
5. DWS DITAKE	COUNTY
6. DWS RISER	DWS PIPE
7. DWS RISER	DWS PIPE
8. 110MM OD UPVC R/W P	CONTROL VALVE
9. 75MM OD UPVC DRAIN (BALCONY)	FIRE PIPE

REVISED BUILDING PLANS OF GROUP HOUSING COLONY MEASURING 22.344 ACRES (LICENSE NO. 41 OF 2010 DATED 07.06.2010) IN SECTOR-93, GURUGRAM, BEING DEVELOPED BY ASHIANA HOUSING LTD. COMPRISING OF TOTAL OF FIVE (5) PHASES.	
1	2nd Floor
2	3rd Floor
3	4th Floor
4	5th Floor
5	6th Floor
6	7th Floor
7	8th Floor
8	9th Floor
9	10th Floor
10	11th Floor
11	12th Floor
12	13th Floor
13	14th Floor
14	Terrace Floor
15	Machine Room Level
16	Roof Level

DOOR SCHEDULE		
NAME	WIDTH	HEIGHT
D1	900	1600
D2	900	2100
D3	750	2100
D4	900	2100
D5	1200	2100
FD1	600	2100
FD2	1000	2100
FD3	1250	2100
FD5	1050	2300
FD6	900	2100
DGd1	1250	2100
SD1	2700	2300
SD2	1800	2300

WINDOW SCHEDULE		
NAME	WIDTH	HEIGHT
W1	900	1200
W2	600	900

WINDOW SCHEDULE		
NAME	WIDTH	HEIGHT
W1	900	1200
W2	600	900

ARCHITECT'S SEAL
 S.Y.E. S. MIRAN
 CA 93/16685
 ASHIANA HOUSING LTD.
 Scale: 1:100
 Drawing No.:
 STILT/GROUND & FIRST FLOOR PLAN (TYPE - 3 + 3T)
 TOWER - 5, 7, 9, 10, 15 & 16
 A-25