

This is a "PROVISIONAL BUILDING PLAN" approved only for the purpose of inviting objections from the general public

AD P.T.P. (HQ) Member B.P.A.C.
PA S.T.P. (HQ) Member Secretary B.P.A.C.
ATP S.T.P. (G) Member B.P.A.C.
ATP S.T.P. (Hr.) Chairman B.P.A.C.

DD(T) MEMBER BPAC

Dinesh Kumar
 PA(HQ)

Checked and found ok for Public Health (Internal) Service only subject to comments in forwarding letter No.OV.....

Idowu
 Superintending Engineer (HQ) for Chief Engineer-I HSVP, Patancheru




PLUMBING LEGEND		LEGEND:-	
SYMBOL	DESCRIPTION	SYMBOL	DESCRIPTION
①	110Ø OD uPVC SP STACK	—	SOIL PIPE
②	110Ø OD uPVC WP STACK	—	WASTE PIPE
③	DWS D/TAKE	■ FT	FLOOR TRAP
④	DWS RISER	□	CUTOUT
⑤	FLUSHING RISER	■ FD	FLOOR DRAIN
⑥	110Ø OD uPVC R.W.P	—	CWS PIPE
⑦	75Ø uPVC DRAIN PIPE(BALCONY)	—	FMS PIPE
		—	CONTROL VALVE
		—	FIRE PIPE

LEVEL-3 AREA CALCULATIONS					
NO.	COEFF.	LENGTH	BREADTH	QUANTITY	AREA (SQ.M)
1	1	28.200	6.800	1	191.760
TOTAL FAR AREA					191.760

OHT AREA CALCULATIONS					
NO.	COEFF.	LENGTH	BREADTH	QUANTITY	AREA (SQ.M)
1	1	8.010	5.800	1	46.458
TOTAL NON-FAR AREA					46.458

LEARNING HUB F.A.R AREA CALCULATIONS			
FLOOR	AREA (IN SQ.M.)	QUANTITY	AREA (SQ.M.)
LEVEL - 1 FLOOR	382.688	1	382.688
LEVEL - 2 FLOOR	99.900	1	99.900
LEVEL - 3 FLOOR	191.760	1	191.760
TOTAL LEARNING HUB F.A.R			674.348

DOOR SCHEDULE		
NAME	WIDTH	HEIGHT
D1	1200	2400
D2	900	2400
FD1	900	1800
FD2	900	1200

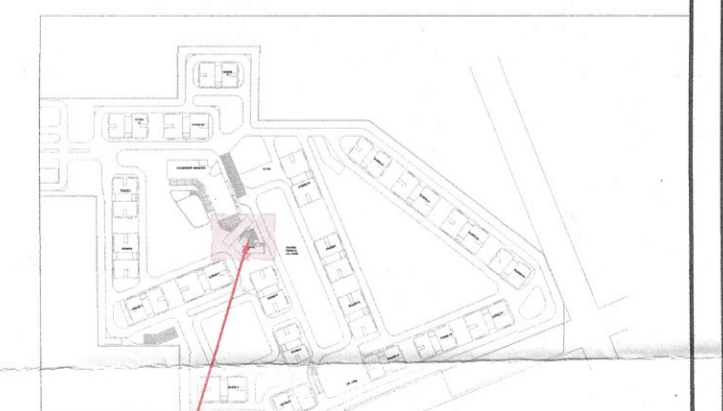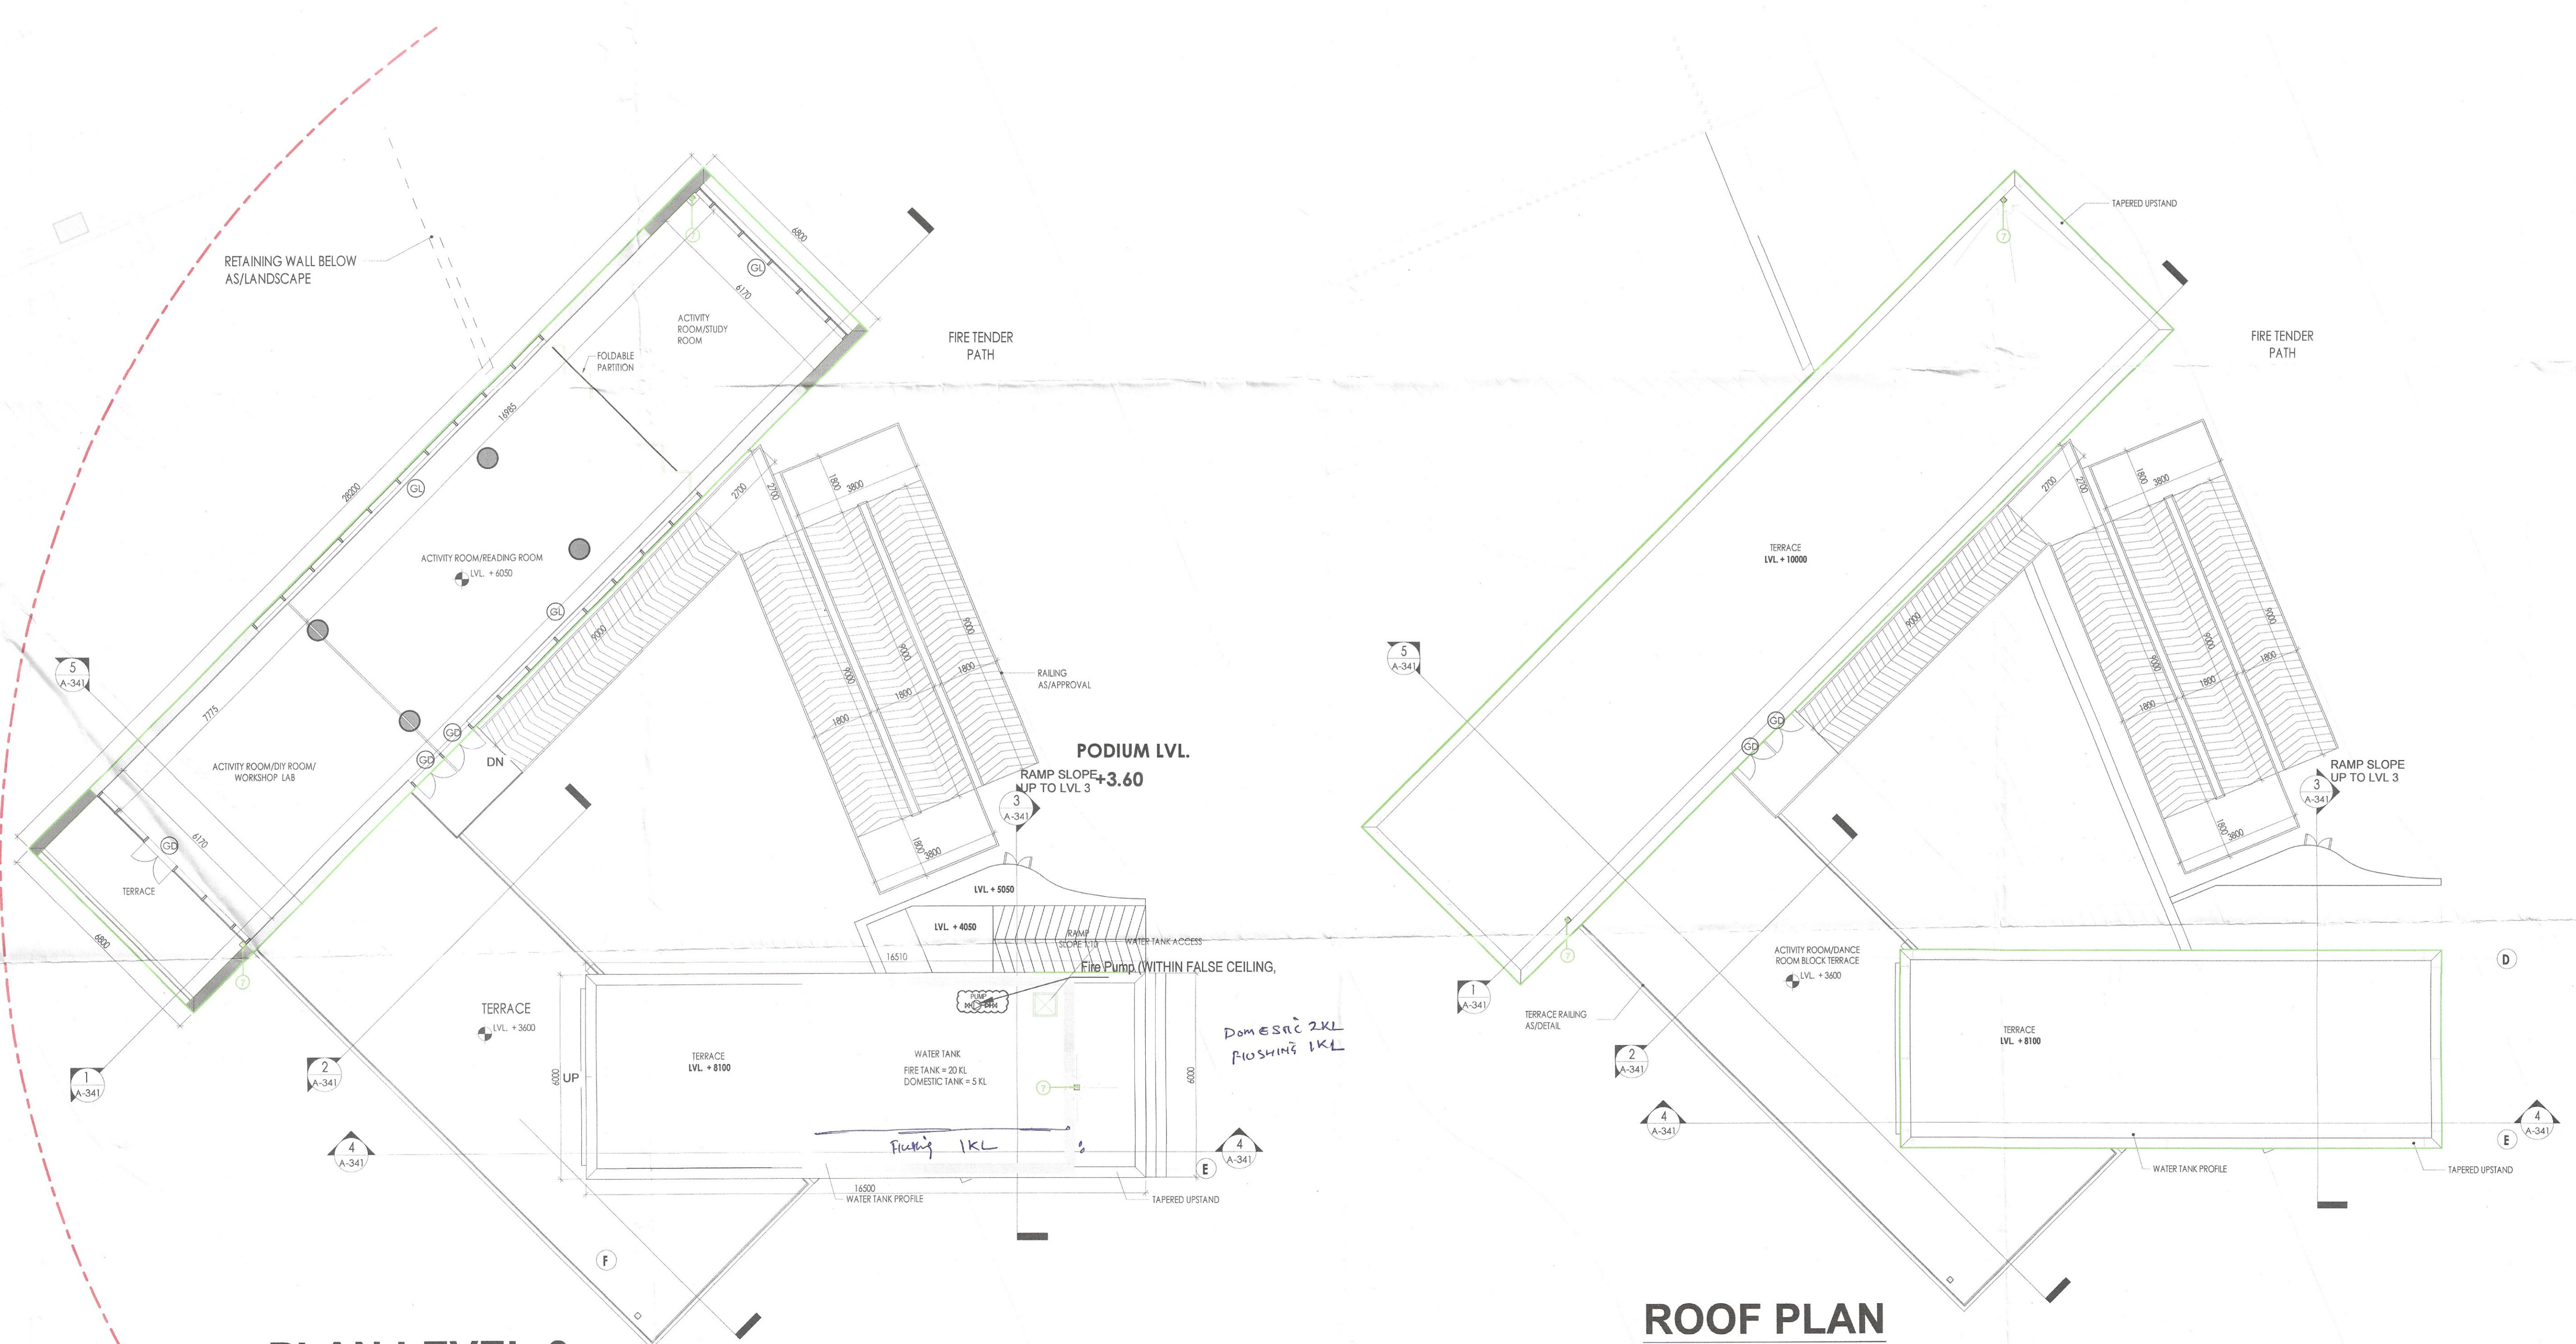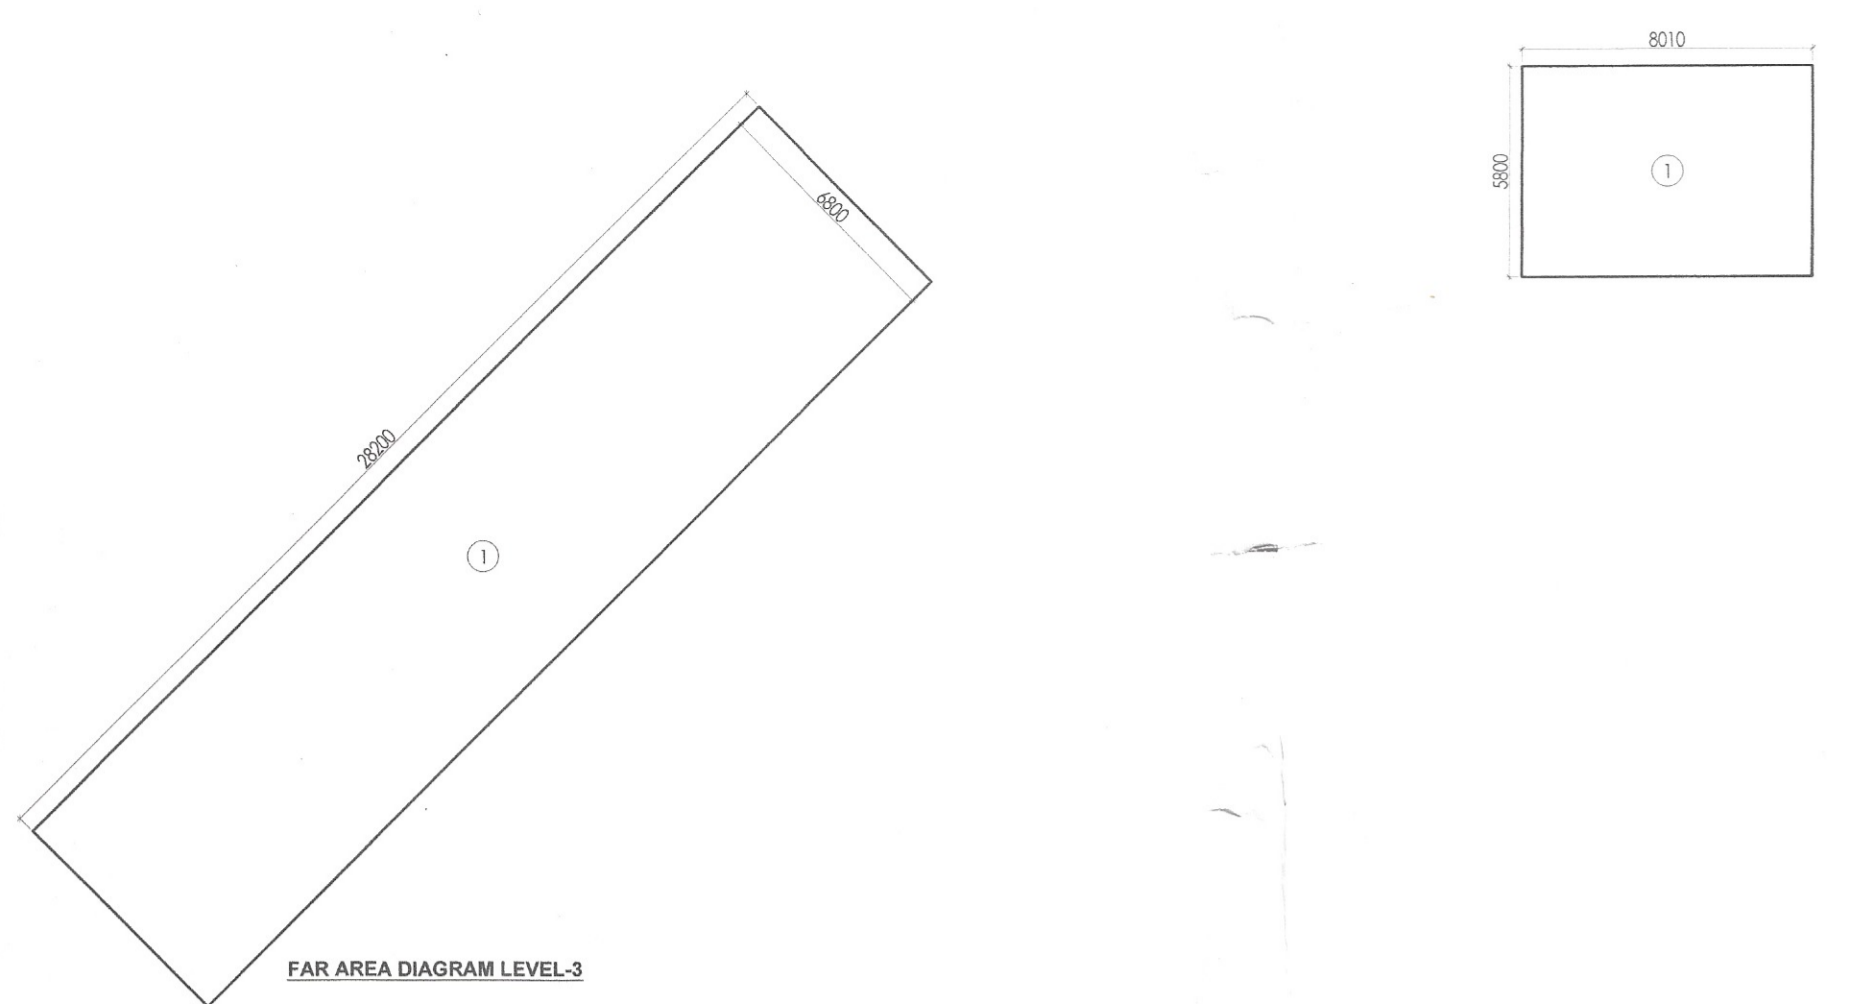

LEARNING HUB TO BE READ WITH THIS OFFICE MEMO NO. DATED :

PROJECT
 Revised Building Plans of Group Housing Colony measuring 22.344 Acres (License No. 41 of 2010 Dated 07.06.2010) in sector-93, Gurugram being developed by Ashiana Housing Ltd. comprising of total of Five (5) phases.

ARCHITECT'S SEAL & SIGNATURE: *Imran*
 SYED MOHD. IMRAN
 CA 93/16665

OWNER/AUTH. SIGN. (Seal of Ashiana Housing Limited)
 Ashiana Housing Limited

Scale: 1 : 200
 Drawing Title: LEVEL-3, ROOF PLAN & AREA DETAILS (LEARNING HUB)
 Drawing No.: A-62